

GROUND FLOOR PLAN
 AREA:- 1796 Q. M.



Management Division
 Department of Health Service
 Ministry of Health & Population




Health Building Infrastructure
 Standard Design Drawings

Job Name:-
 PRIMARY HOSPITAL CLASS B
 TYPE 1
 RCC Frame Structure
 Two Storied
 SCALE:-
 DATE :

Drawing Title
 GROUND FLOOR
 PLAN

Sheet no:
 AR/ 01
 01/05

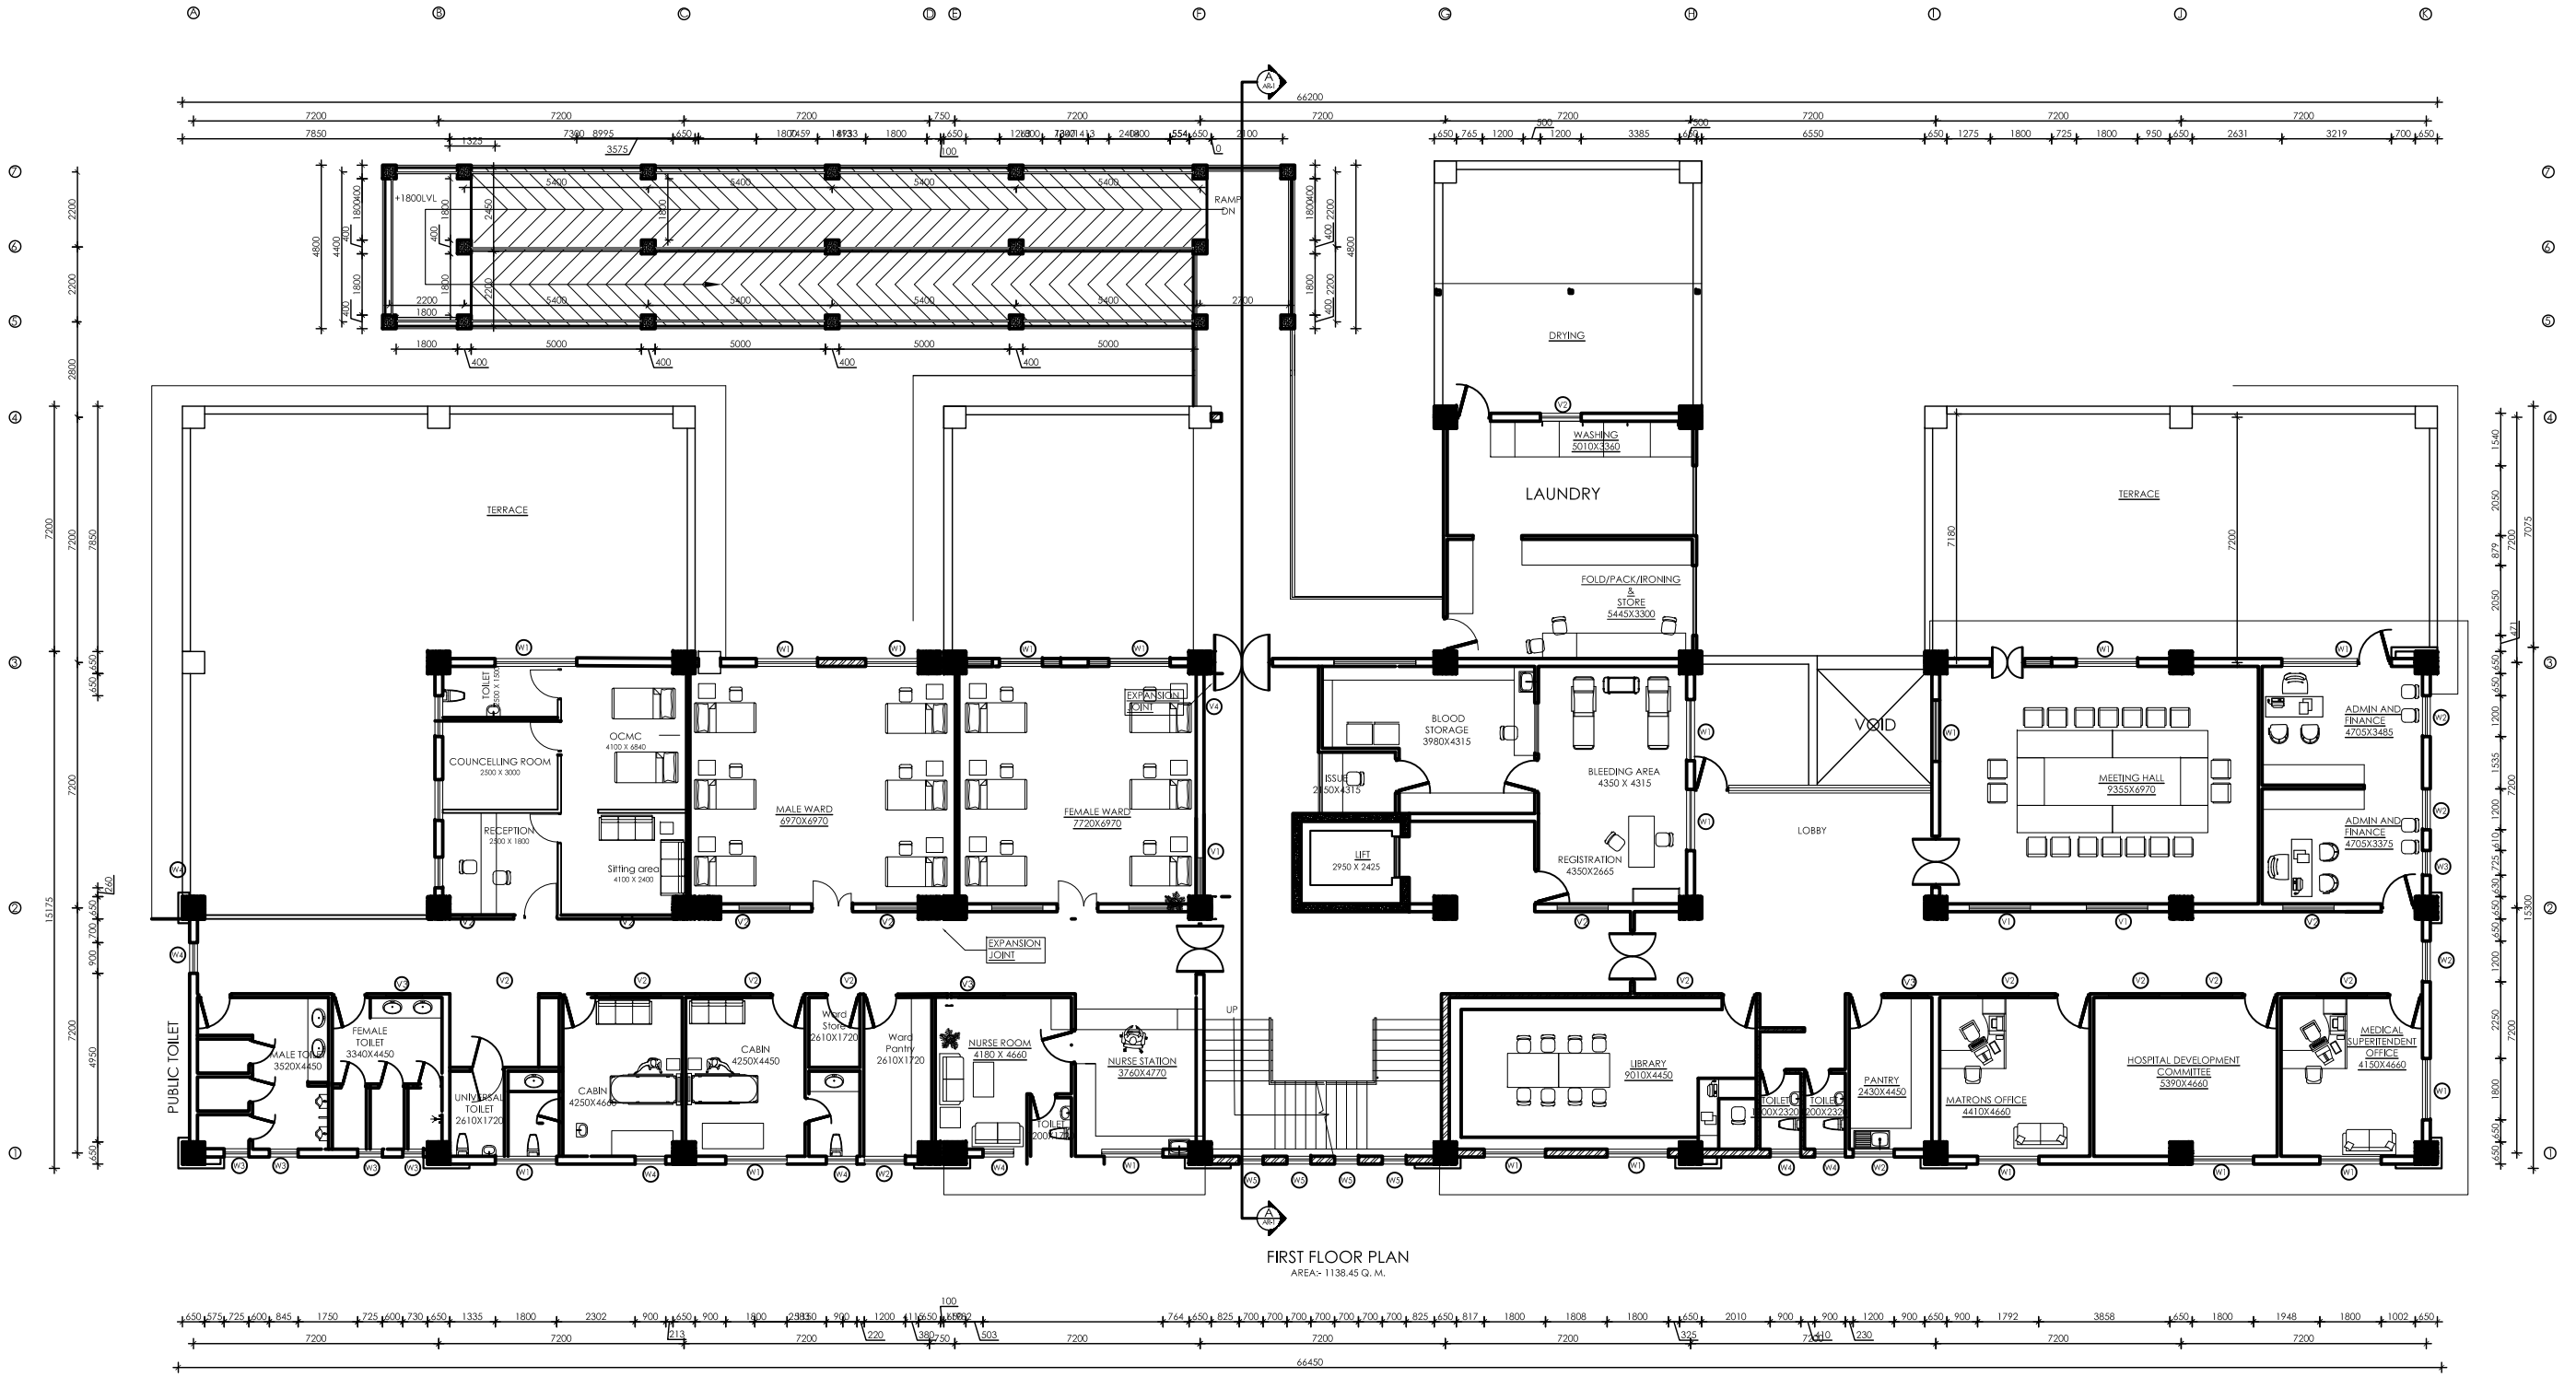

Management Division
Department of Health Service
Ministry of Health & Population



Health Building Infrastructure
Standard Design Drawings

Job Name:-
PRIMARY HOSPITAL CLASS B
TYPE 1
RCC Frame Structure
Two Storied
SCALE:-
DATE :

Drawing Title
GROUND FLOOR PLAN

Sheet no:
AR/ 01
01/05